


GENERAL NOTE:
 1) FOR LIGHTING FIXTURE SCHEDULE SEE ELOH02
 2) PYLON LOCATION INDICATED IS FOR CONCEPTUAL INTENT ONLY. FINAL LOCATION WILL REQUIRE COORDINATION. SYMBOL SHOWN DOES NOT REPRESENT THE PYLON SHAPE OR DESIGN.

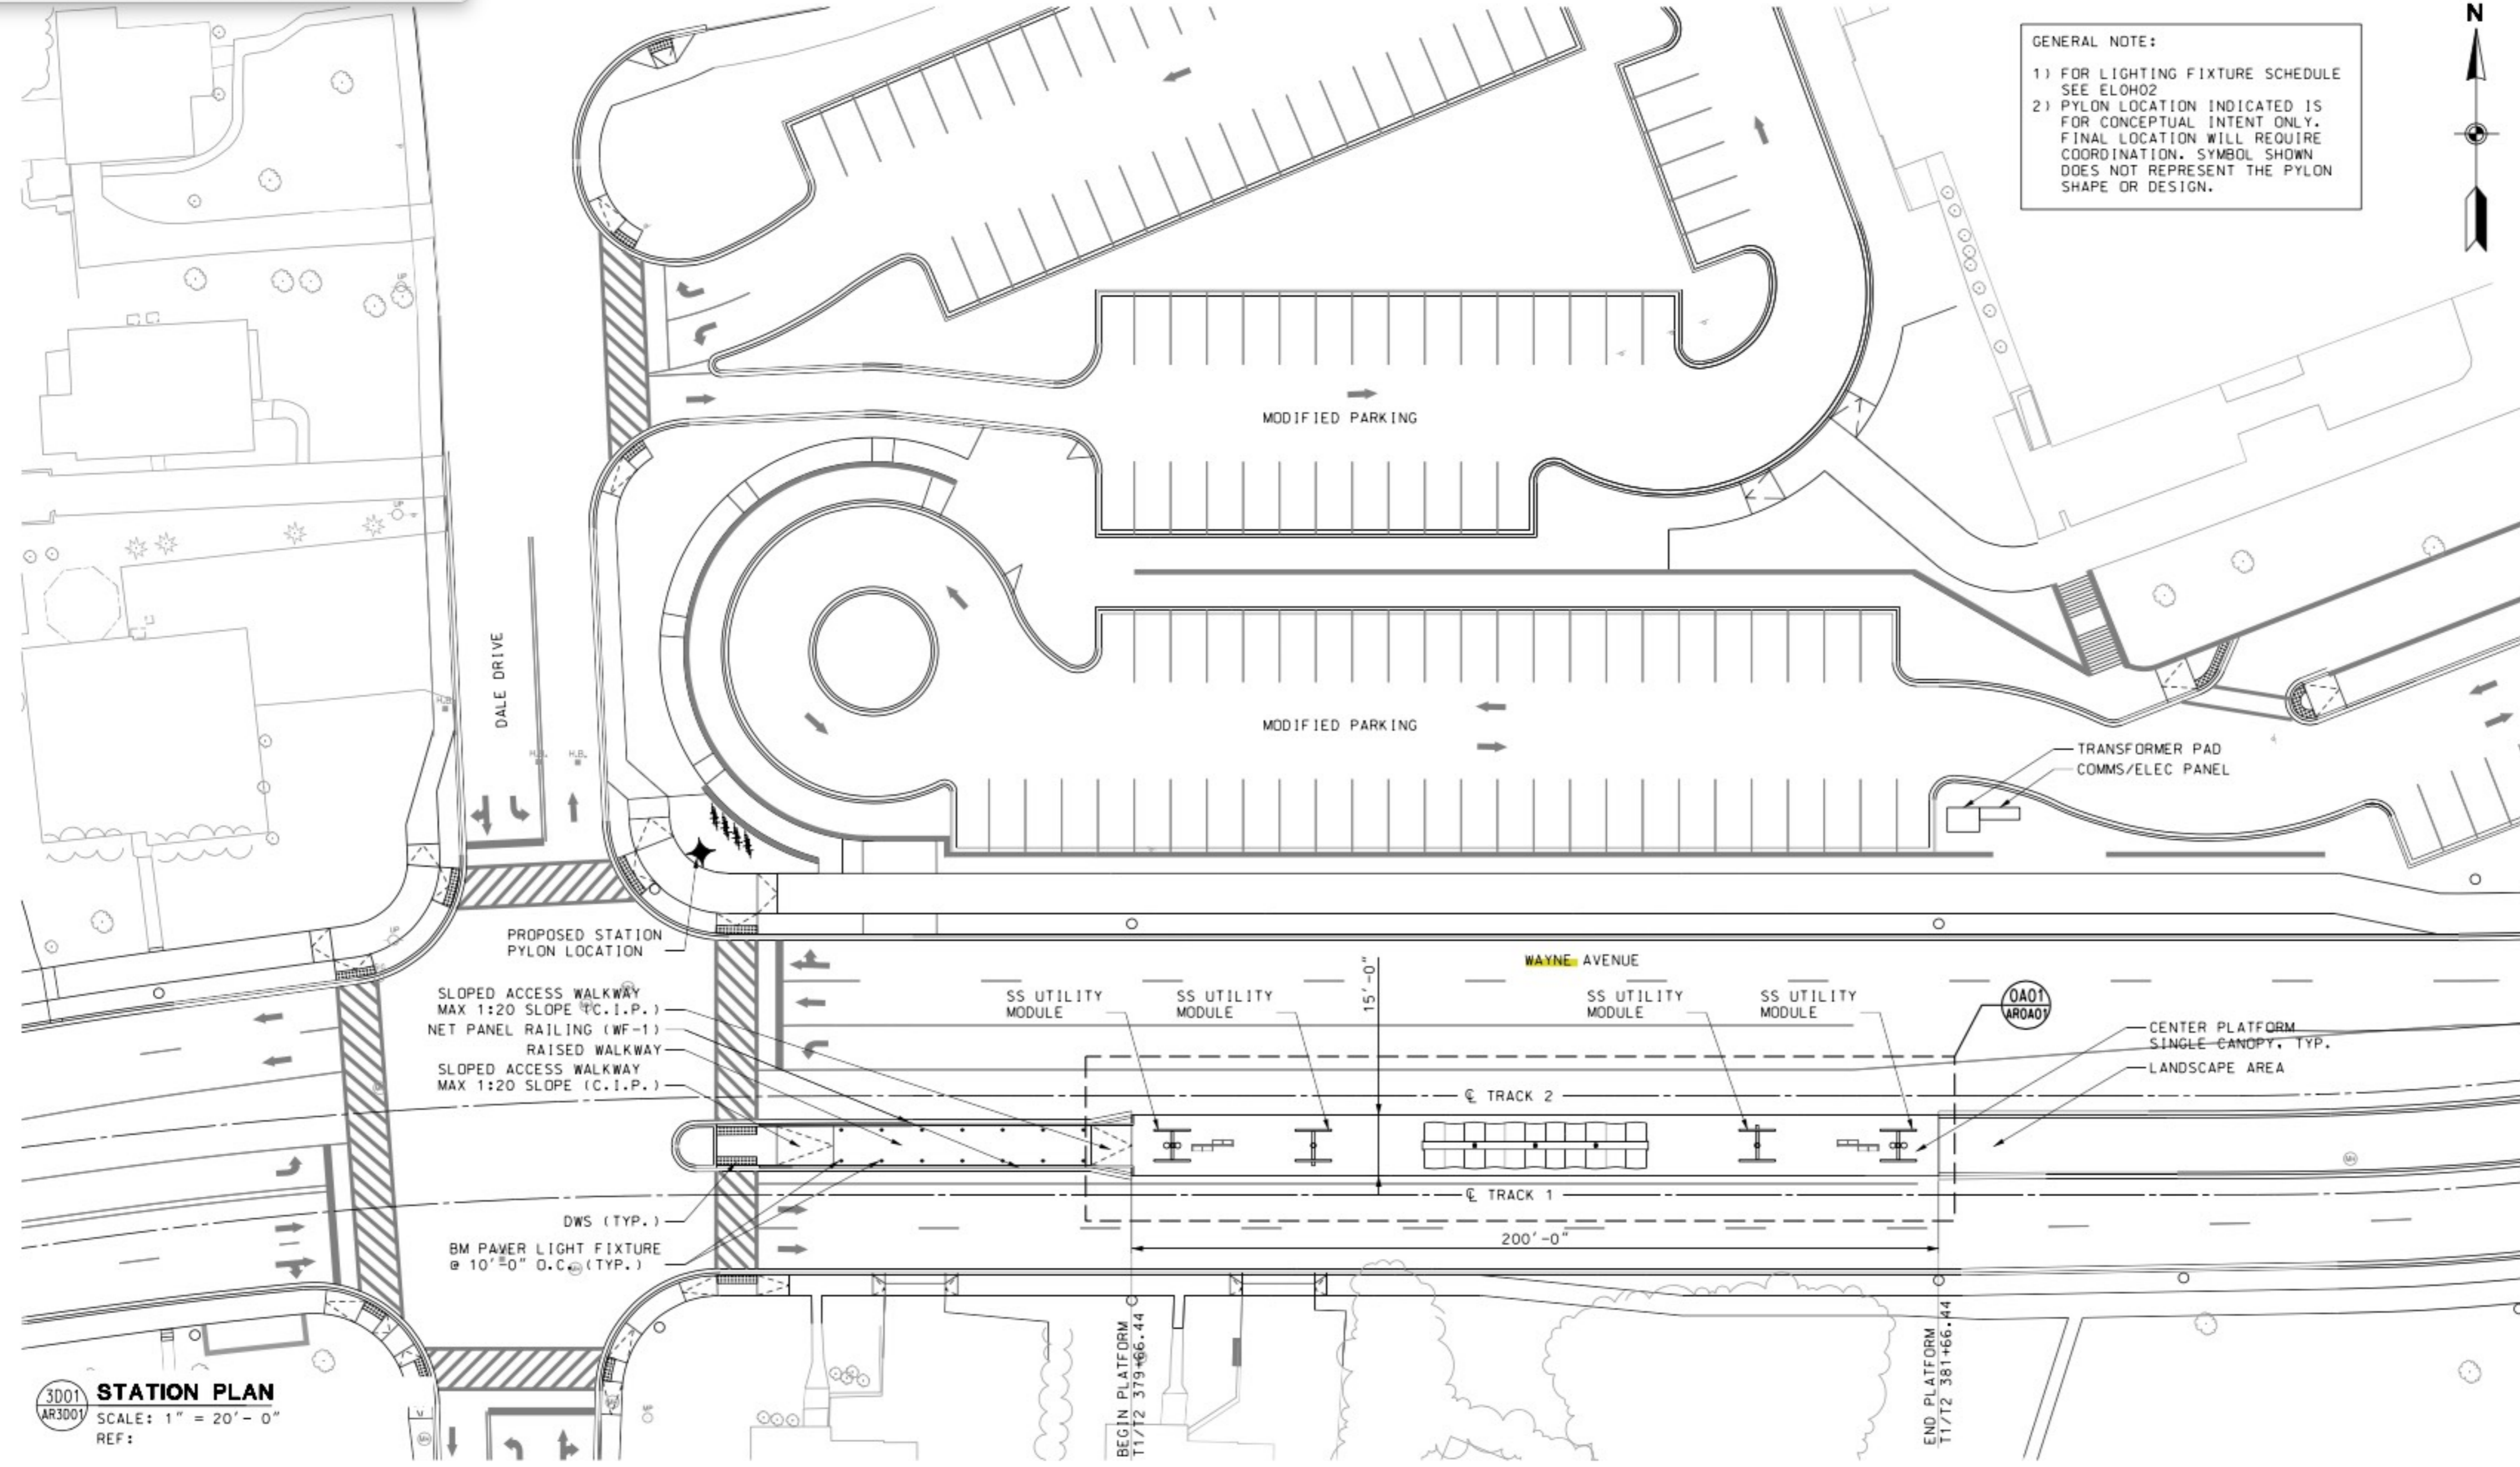

3001 STATION PLAN
 SCALE: 1" = 20'-0"
 REF:

MARYLAND DEPARTMENT OF TRANSPORTATION

MARYLAND TRANSIT ADMINISTRATION

Gannett Fleming

PROFESSIONAL CERTIFICATION
 I hereby certify that these documents were prepared or approved by me, and that I am a duly licensed professional architect under the laws of the State of Maryland.
 License No. Expiration Date

NO.	DESCRIPTION	BY	DATE
REVISIONS			

CONTRACT DRAWINGS
 PURPLE LINE LIGHT RAIL
 DALE DRIVE STATION
 STATION PLAN
 DATE: JUNE 2014 SCALE: 1" = 20'

CONTRACT NO.
 T-1042-0240
 DRAWING NO.
 AR3D01
 SHEET NO.
 358 OF 425

c:\pwworking\mtopw\wro-luis_opestegu\0179683\1042pAR3d1.dgn 6/18/2014